



FRONT ELEVATION

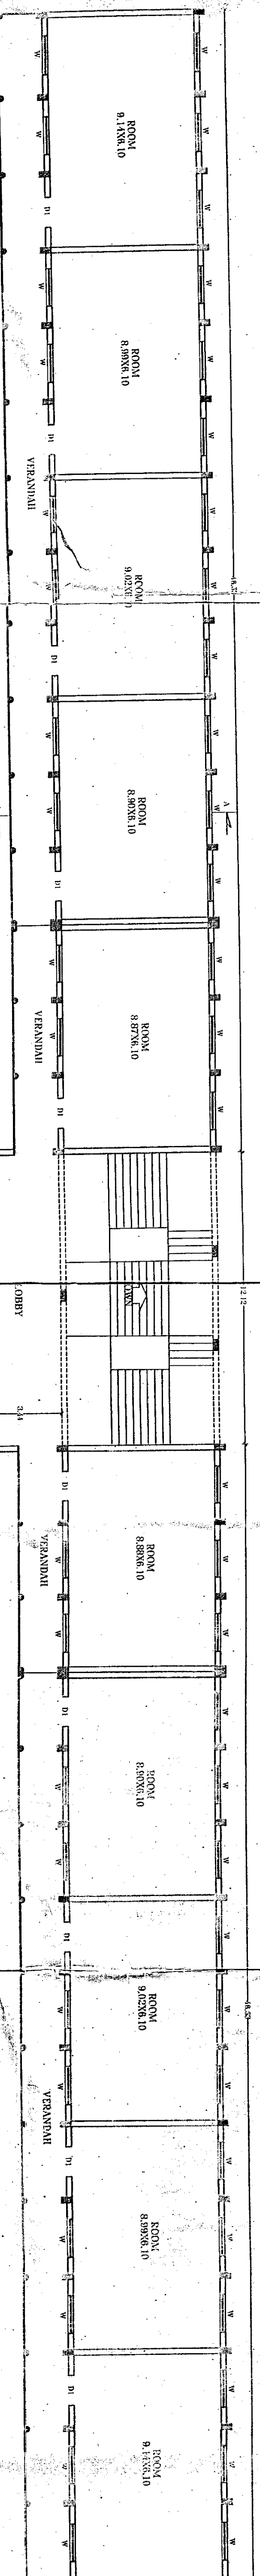


FIRST FLOOR PLAN

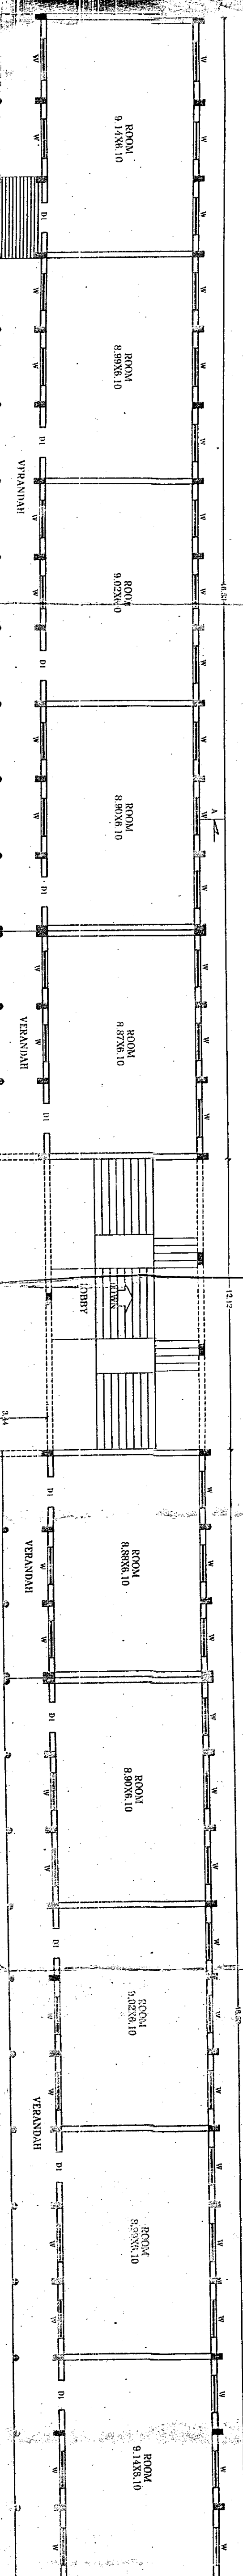

GROUND FLOOR PLAN

APPROVED
 Building license fee of
 Rs. 100/- is returned in M.R.
 to the Municipal Engineer,
 Kumbakonam, dated 11/11/12
 from the Architect
 R. S. S. Srinivasan
 President
 Kothichery Architects


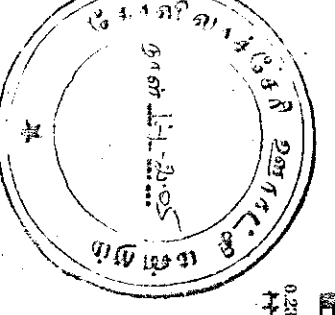


NOTES
 1. MANUAL / AUTOMATIC FIRE ALARM SYSTEM, FIRE
 EXTINGUISHERS, AND ALL THE ELECTRICAL AND
 MECHANICAL WORKS TO BE PROVIDED AS PER THE
 RECOMMENDATIONS AND TO THE SATISFACTION OF
 THE DIRECTORATE OF FIRE SERVICE.
 2. RAIN WATER HARVESTING SYSTEMS ARE PROVIDED
 AS PER THE STANDARD SPECIFICATIONS IN G.O.S.
 NO. HR. MS. 100 DATED 11.10.12.

SCHEDULE OF JOINERY	1.25X2.12
DI DOOR	1.32X1.37
W WINDOW	1.32X1.37
PLANTH AREA OF GROUND FLOOR : 977.18 (0051 SFT)	
PLANTH AREA OF FIRST FLOOR : 977.18 (0051 SFT)	
ALL DIMENSIONS ARE IN METRE.	
SCALE: 1:150	

PLAN SHOWING THE GROUND FLOOR & FIRST FLOOR
 BUILDING FOR ANNAL COLLEGE OF ARTS & SCIENCE
 AT R.S NO. 112/EB.113/1, 114/1, 2 & 115,
 KOYILACHERI VILLAGE, KUMBAKONAM TALUK.

ENGINEER
 JAYARAM ANTHEERTE
 R. S. S. Srinivasan, I.E.S., I.E. Tech.
 CONSULTING CIVIL ENGINEER,
 81, MULTI STREET,
 KUMBAKONAM - 612 001.

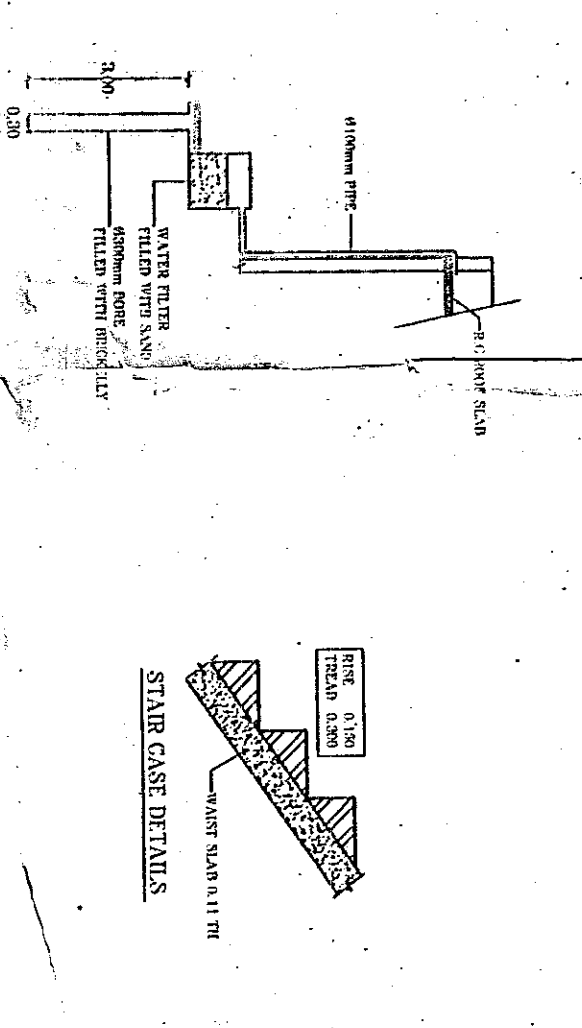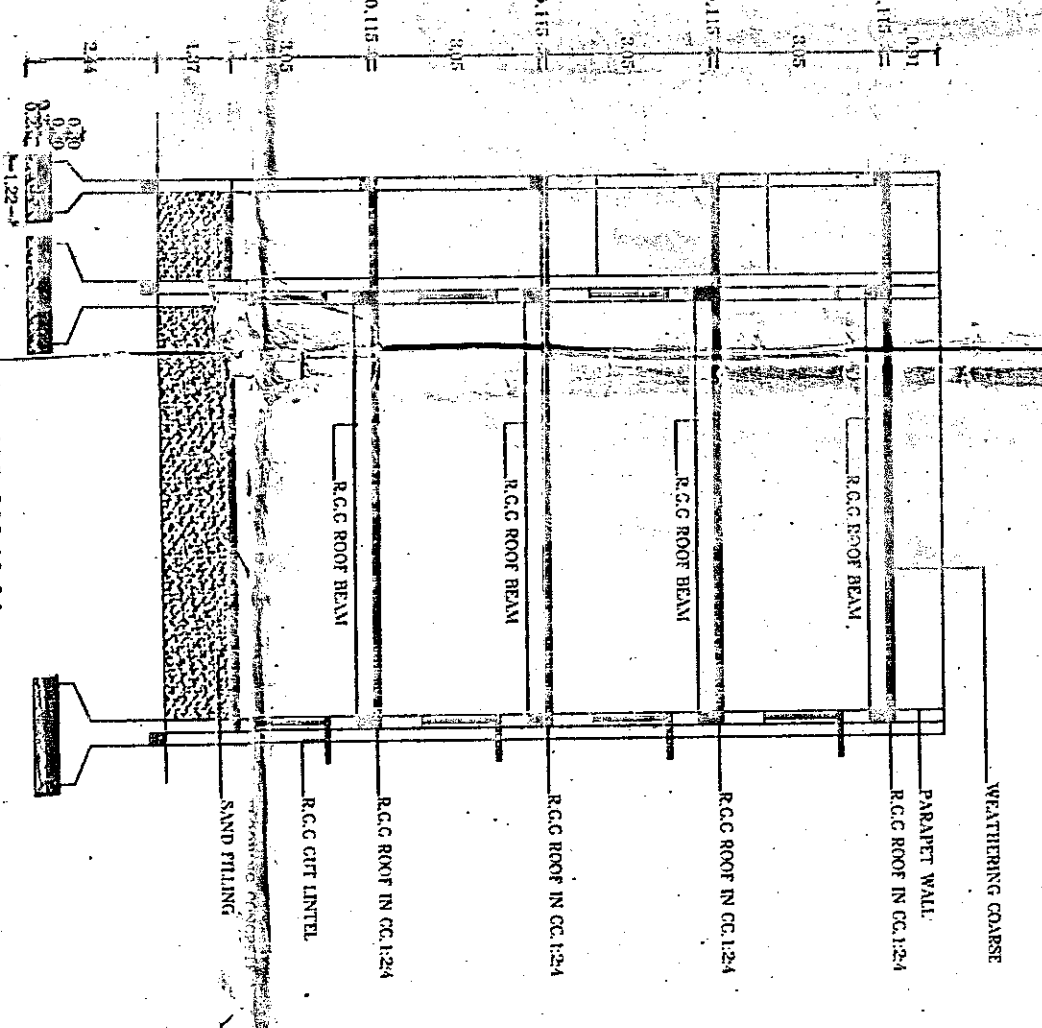

RAIN WATER HARVESTING