



FRONT ELEVATION

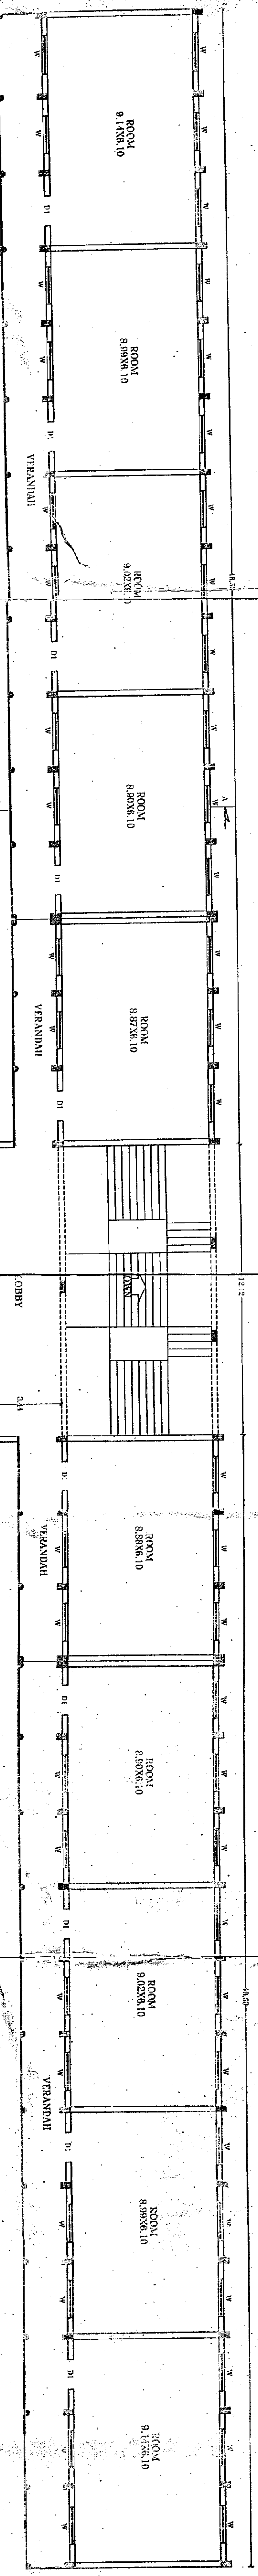


FIRST FLOOR PLAN

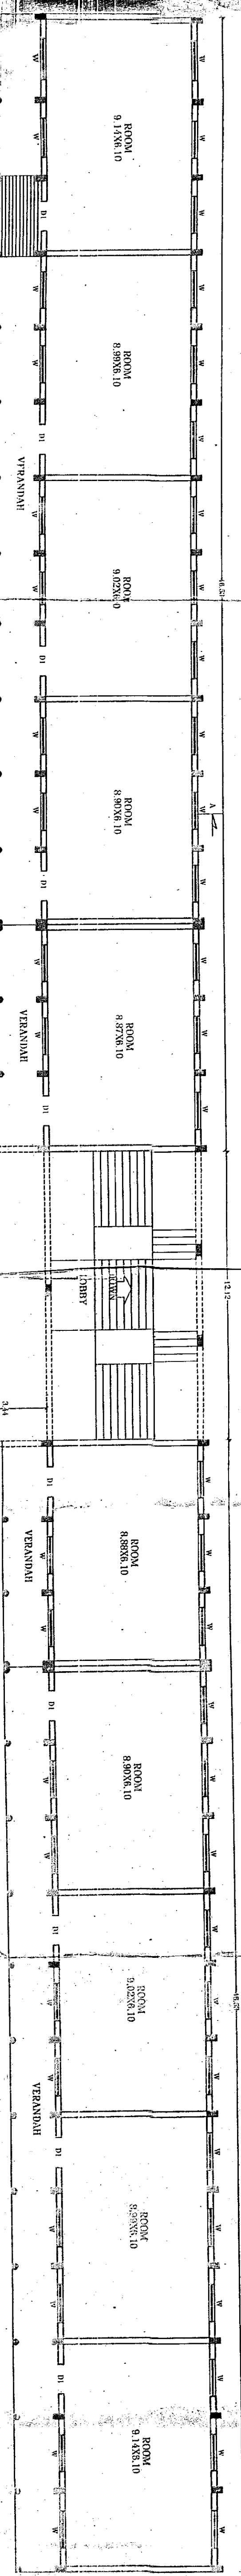

GROUND FLOOR PLAN

APPROVED  
 Building license fee of  
 Rs. 100/- is returned in M.R.  
 to the Architect, No. 85, V.L.D.  
 from the Government of Madras  
 dated 10/11/53.  
 R. S. S. Srinivasan  
 President  
 Kothichery Architects

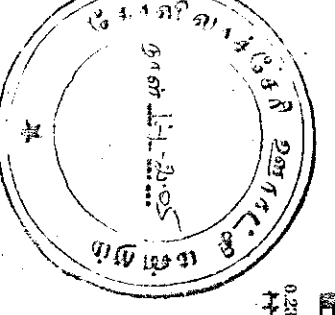

NOTES  
 MANUAL / AUTOMATIC FIRE ALARM SYSTEM, FIRE  
 EXTINGUISHERS AND ALL THE OTHERS ARE  
 PROVIDED ACCORDING TO THE SPECIFICATIONS &  
 RECOMMENDATIONS AND TO THE SATISFACTION OF  
 THE DIRECTORATE OF FIRE SERVICE.  
 RAIN WATER HARVESTING SYSTEMS ARE PROVIDED  
 AS PER THE STANDARD SPECIFICATIONS IN G.O.S.  
 NO. HR. 4505 DATED 11.10.52.

SCHEDULE OF JOINTS	1.25X1.10
DI DOOR	1.25X1.10
W WINDOW	1.25X1.10
PLANT AREA OF GROUND FLOOR : 977.18 (0851 SFT)	
PLANT AREA OF FIRST FLOOR : 977.18 (0851 SFT)	
ALL DIMENSIONS ARE IN METRE.	
SCALE: 1:150	

PLAN SHOWING THE GROUND FLOOR & FIRST FLOOR  
 BUILDING FOR ANNAL COLLEGE OF ARTS & SCIENCE  
 AT R.S NO. 112/EB.113/1, 114/1, 2 & 115,  
 KOYIACHERI VILLAGE, KUMBARKONAM TALUK.

R. S. S. Srinivasan  
 CONSULTING CIVIL ENGINEER,  
 NO. 85, V.L.D. STREET,  
 81, MULTI STREET,  
 KUMBARKONAM - 612 001.

