
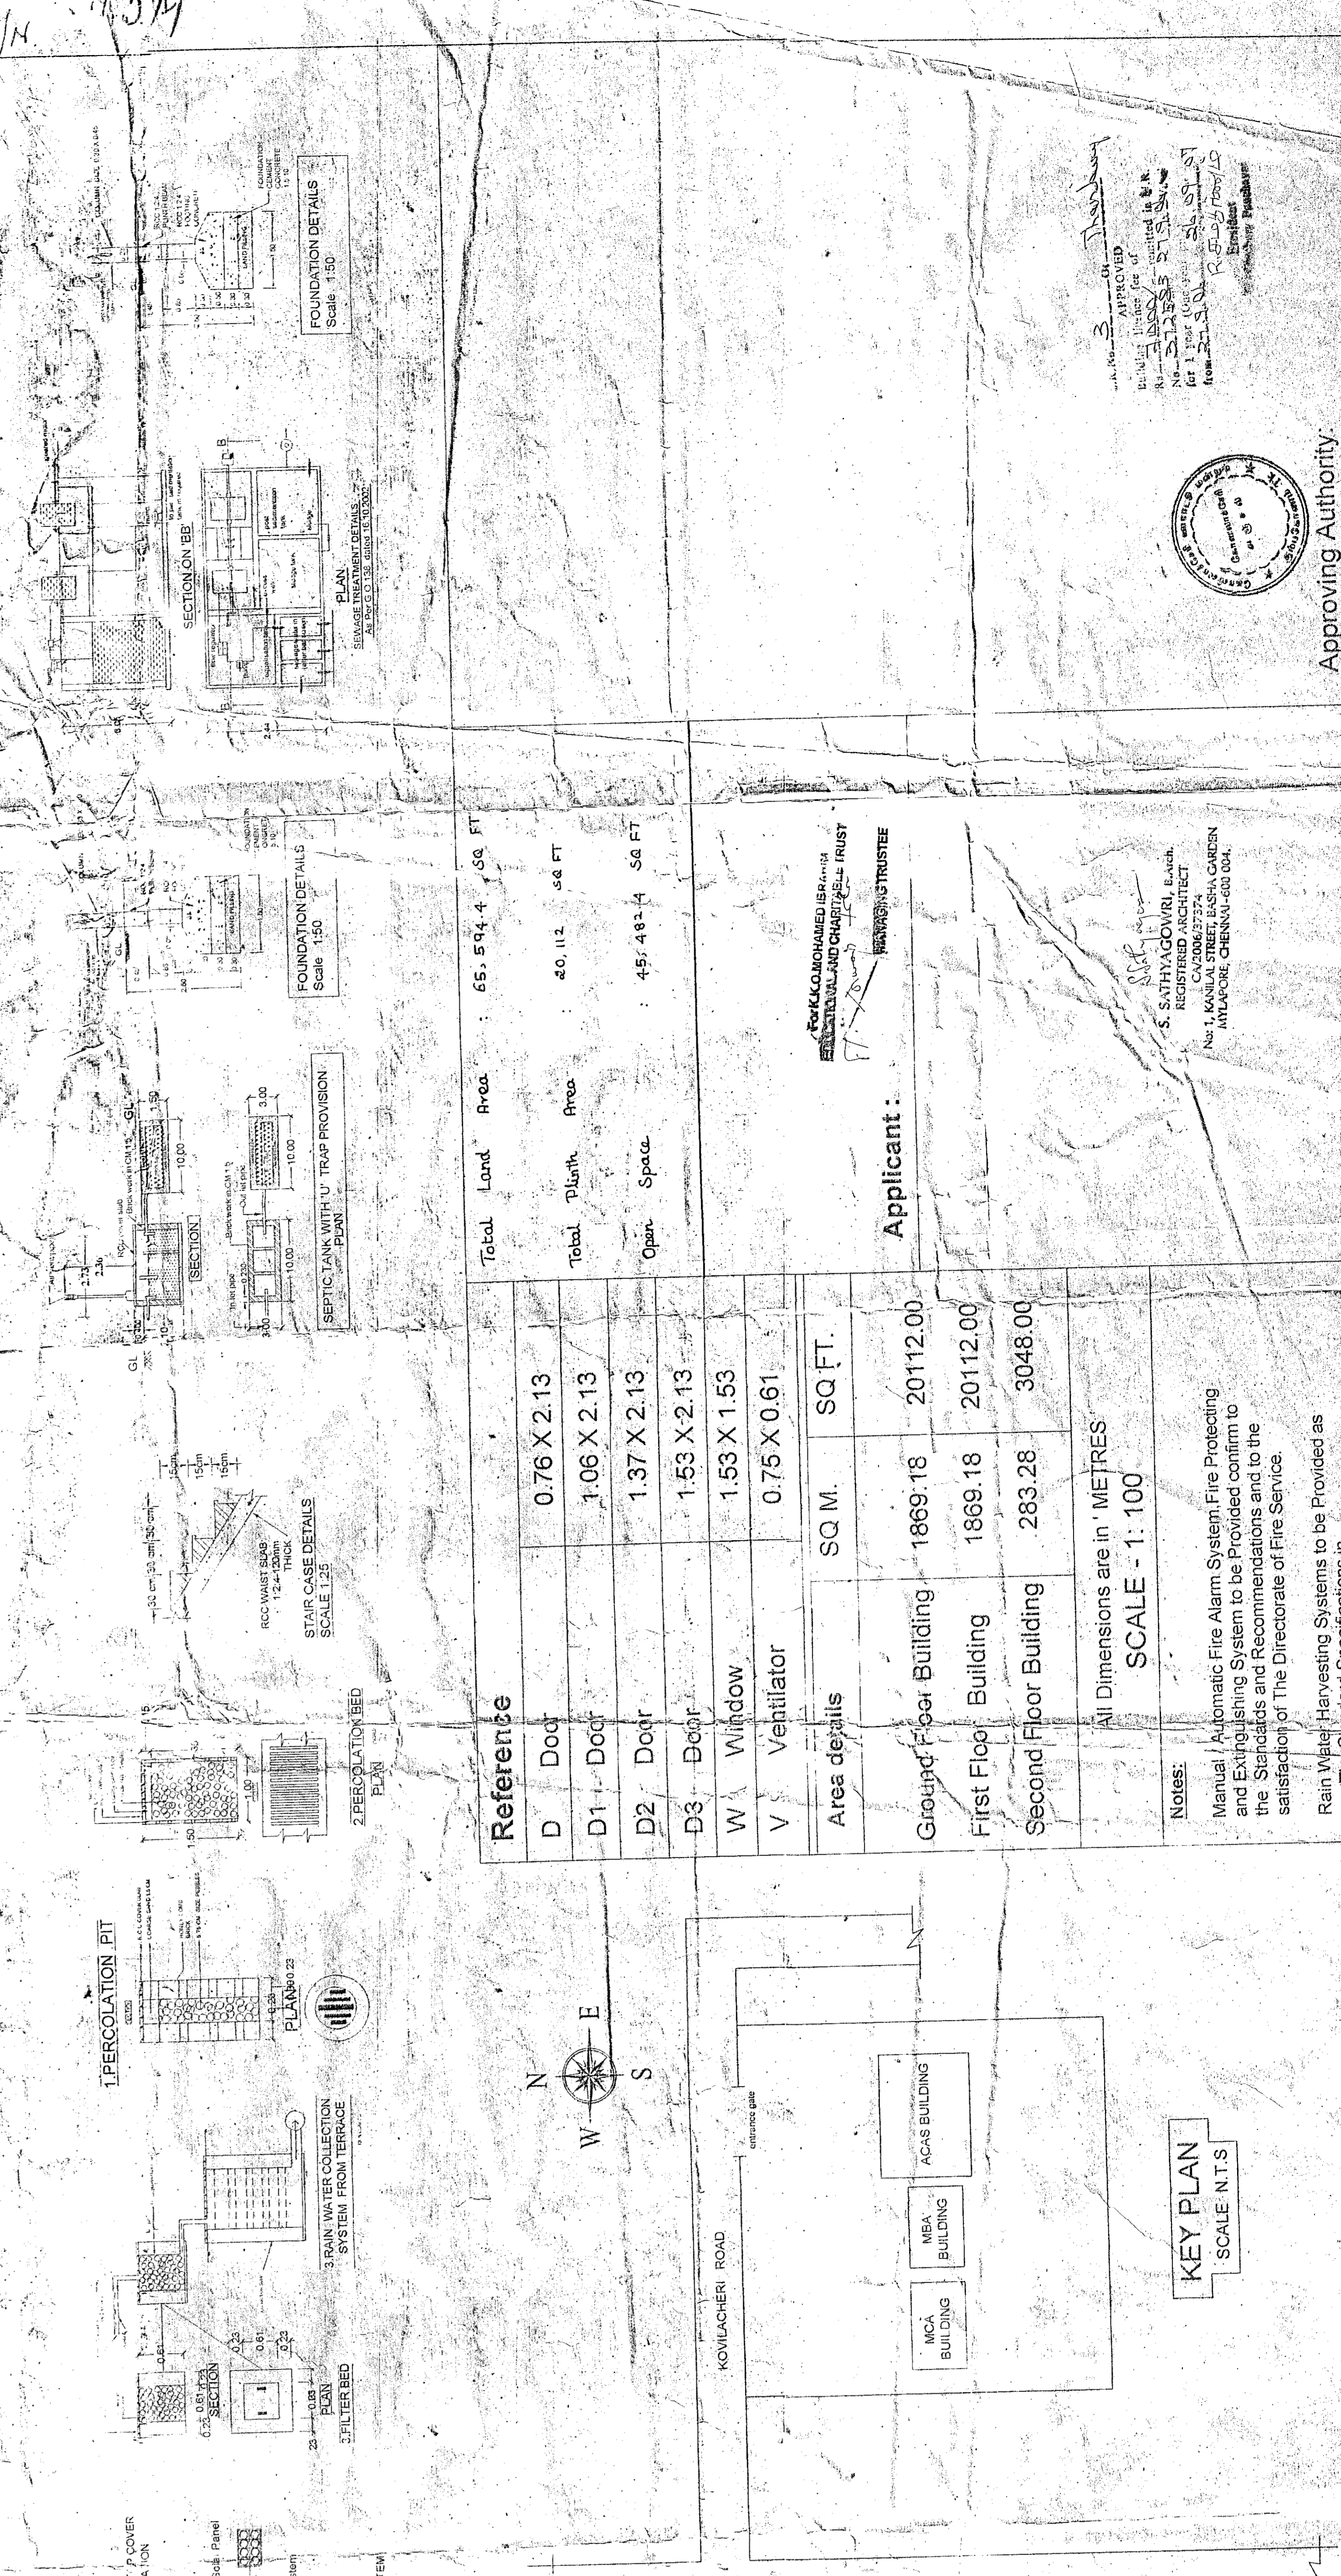
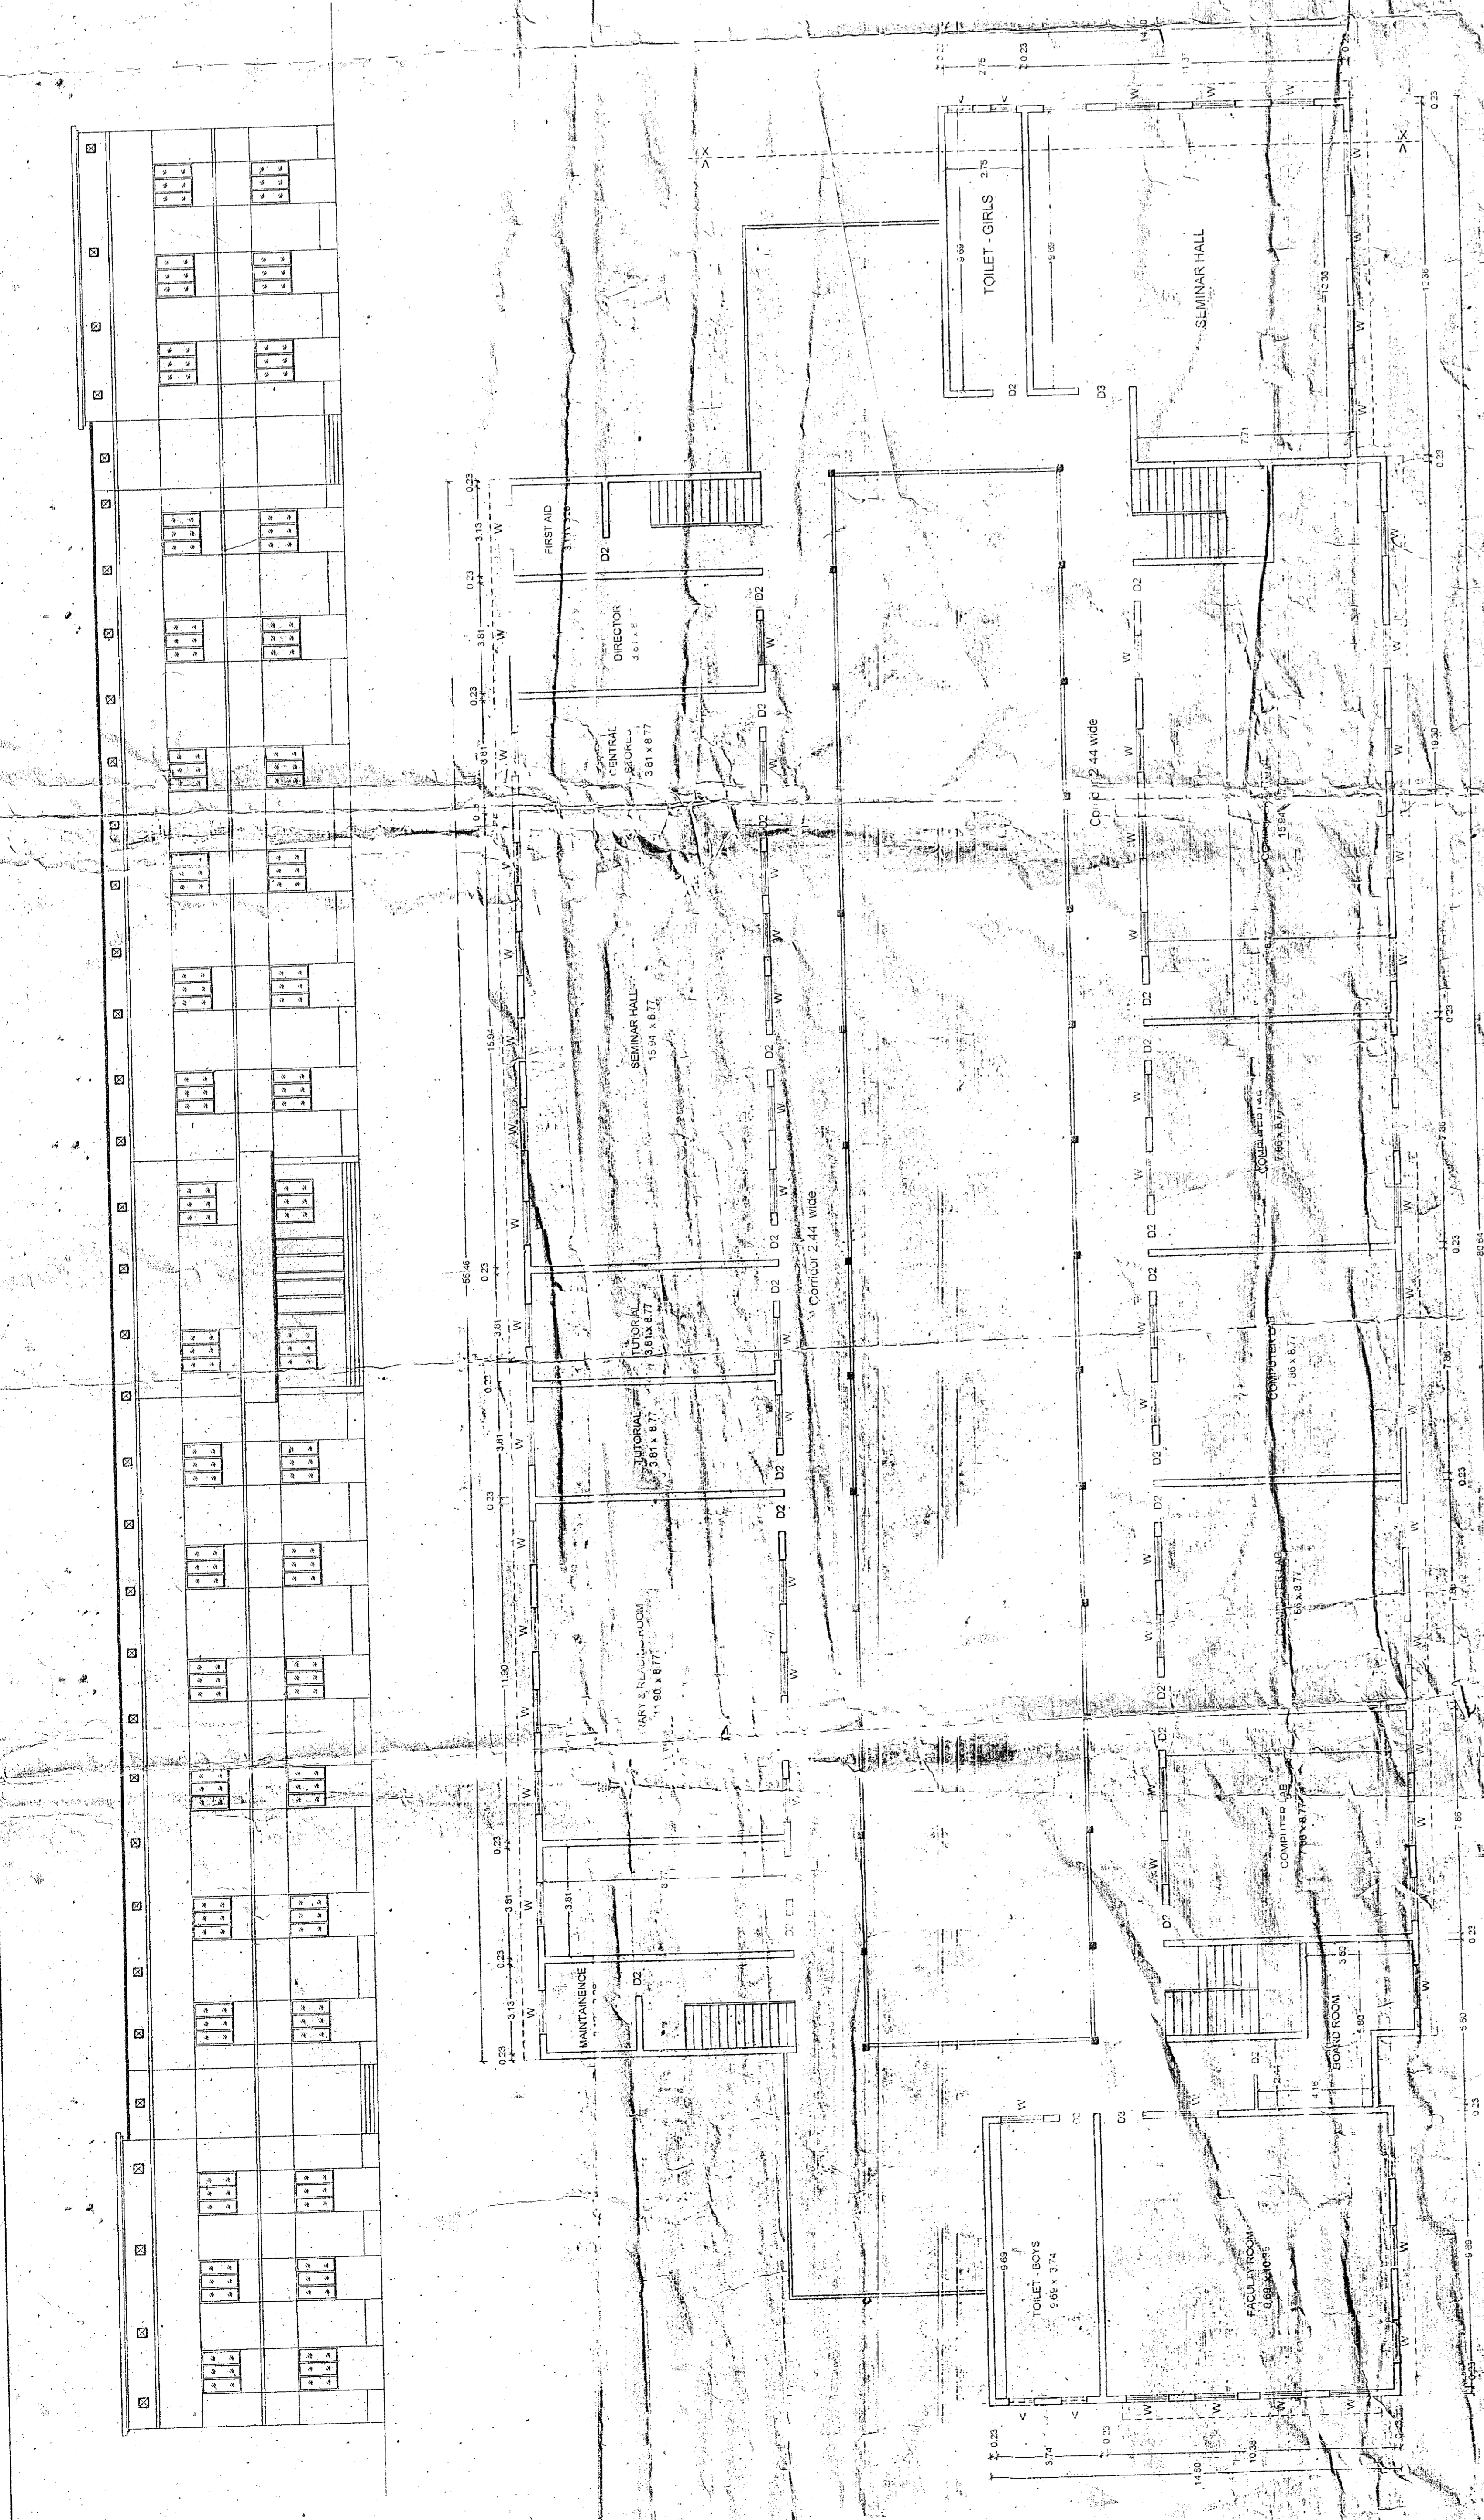


Plan showing the Building Details for M.C.A. Programme in
 Annai College of Arts & Science at R.S.Nos. 113 / 2
 Kovilacheri Village, Kumbakonam Taluk, Thanjavur District.

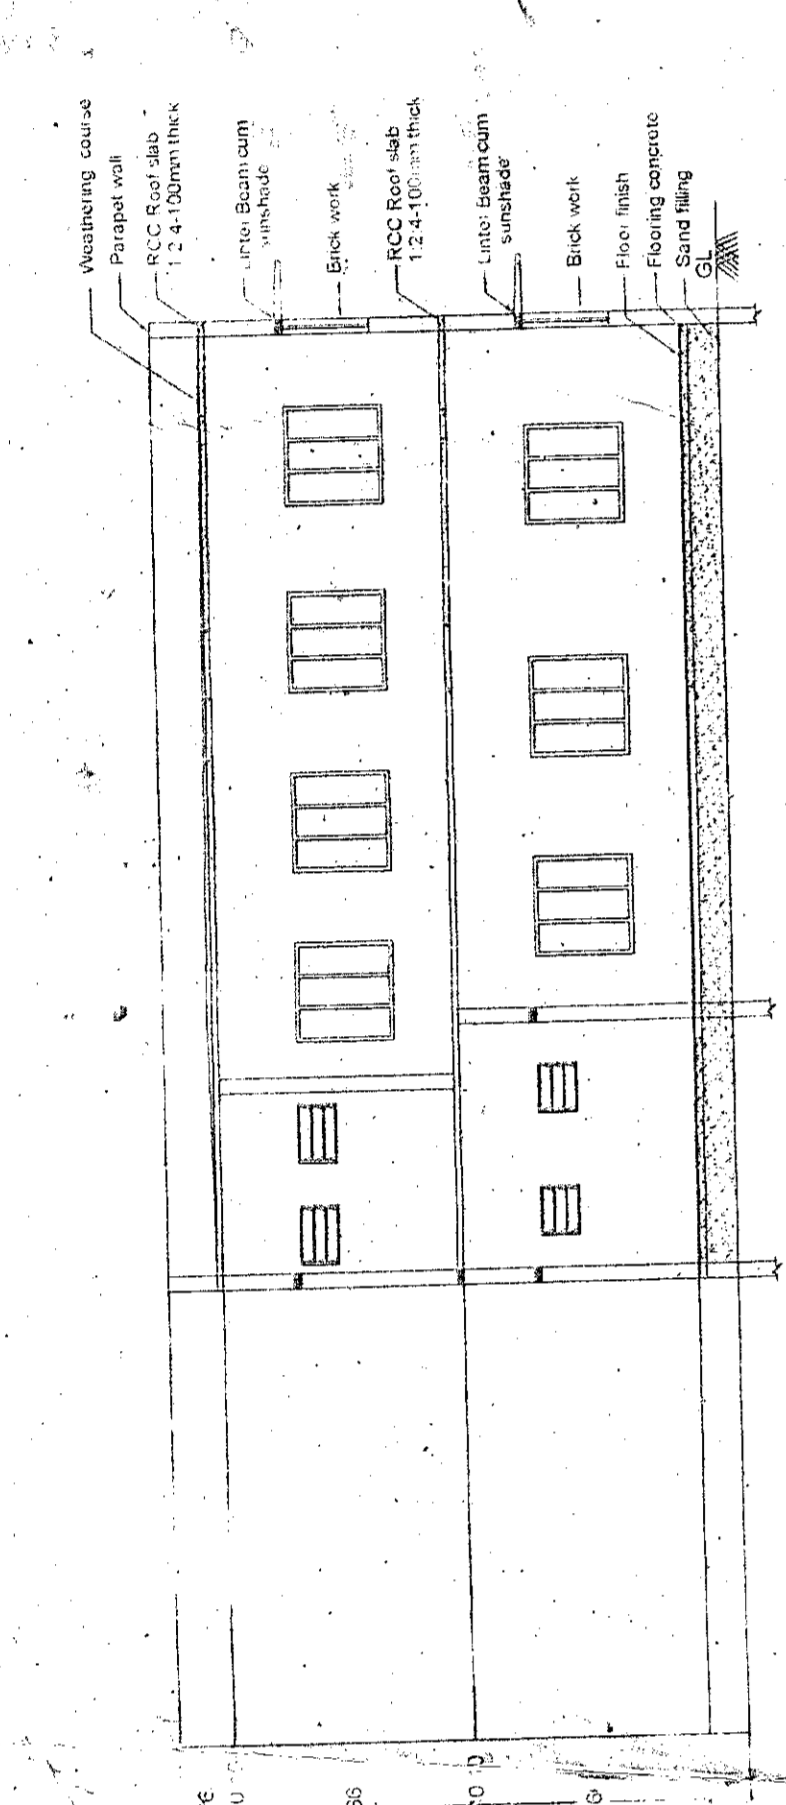

Reference	Area details	SQ. M.	SQ. FT.
D Door	0.76 X 2.13		
D1 - Door	1.06 X 2.13		
D2 Door	1.37 X 2.13		
D3 - Door	1.53 X 2.13		
W Window	1.53 X 1.53		
V Ventilator	0.75 X 0.61		
Total Land Area : 65,814.47 SQ. FT.			
Total Plinth Area : 40,113.48 FT			
Open Space : 457,481.4 SQ. FT.			

Applicant:	Ground Floor Building	1869.18	20112.00
	First Floor Building	1869.18	20112.00
	Second Floor Building	283.28	3048.00

NOTE:
 Manual / Automatic Fire Alarm System Fire Protecting and Extinguishing System to be Provided conform to the Standards and Recommendations and to the satisfaction of The Directorate of Fire Service.
 Rain Water Harvesting Systems to be Provided as per The Standard Specifications in G.O.M.S No. 136, MAWS Dated 11.10.2002.

APPROVED ARCHITECT
 S. SATHYANARAYANAN
 REGISTERED ARCHITECT
 NO. 1, MANJALI STREET, KOVILACHERI
 THANJAVUR, CHENNAI-605 004

APPROVING AUTHORITY
 ENGINEER

KEY PLAN
 SCALE 1:100

SCALE - 1:100
 All Dimensions are in METRES

MANUAL / AUTOMATIC FIRE ALARM SYSTEM FIRE PROTECTING AND EXTINGUISHING SYSTEM TO BE PROVIDED CONFORM TO THE STANDARDS AND RECOMMENDATIONS AND TO THE SATISFACTION OF THE DIRECTORATE OF FIRE SERVICE.
 RAIN WATER HARVESTING SYSTEMS TO BE PROVIDED AS PER THE STANDARD SPECIFICATIONS IN G.O.M.S NO. 136, MAWS DATED 11.10.2002.

APPROVED ARCHITECT
 S. SATHYANARAYANAN
 REGISTERED ARCHITECT
 NO. 1, MANJALI STREET, KOVILACHERI
 THANJAVUR, CHENNAI-605 004

APPROVING AUTHORITY
 ENGINEER